



3 CASITA KITCHEN LIGHTING PLAN
SCALE: 1/4" = 1'-0"

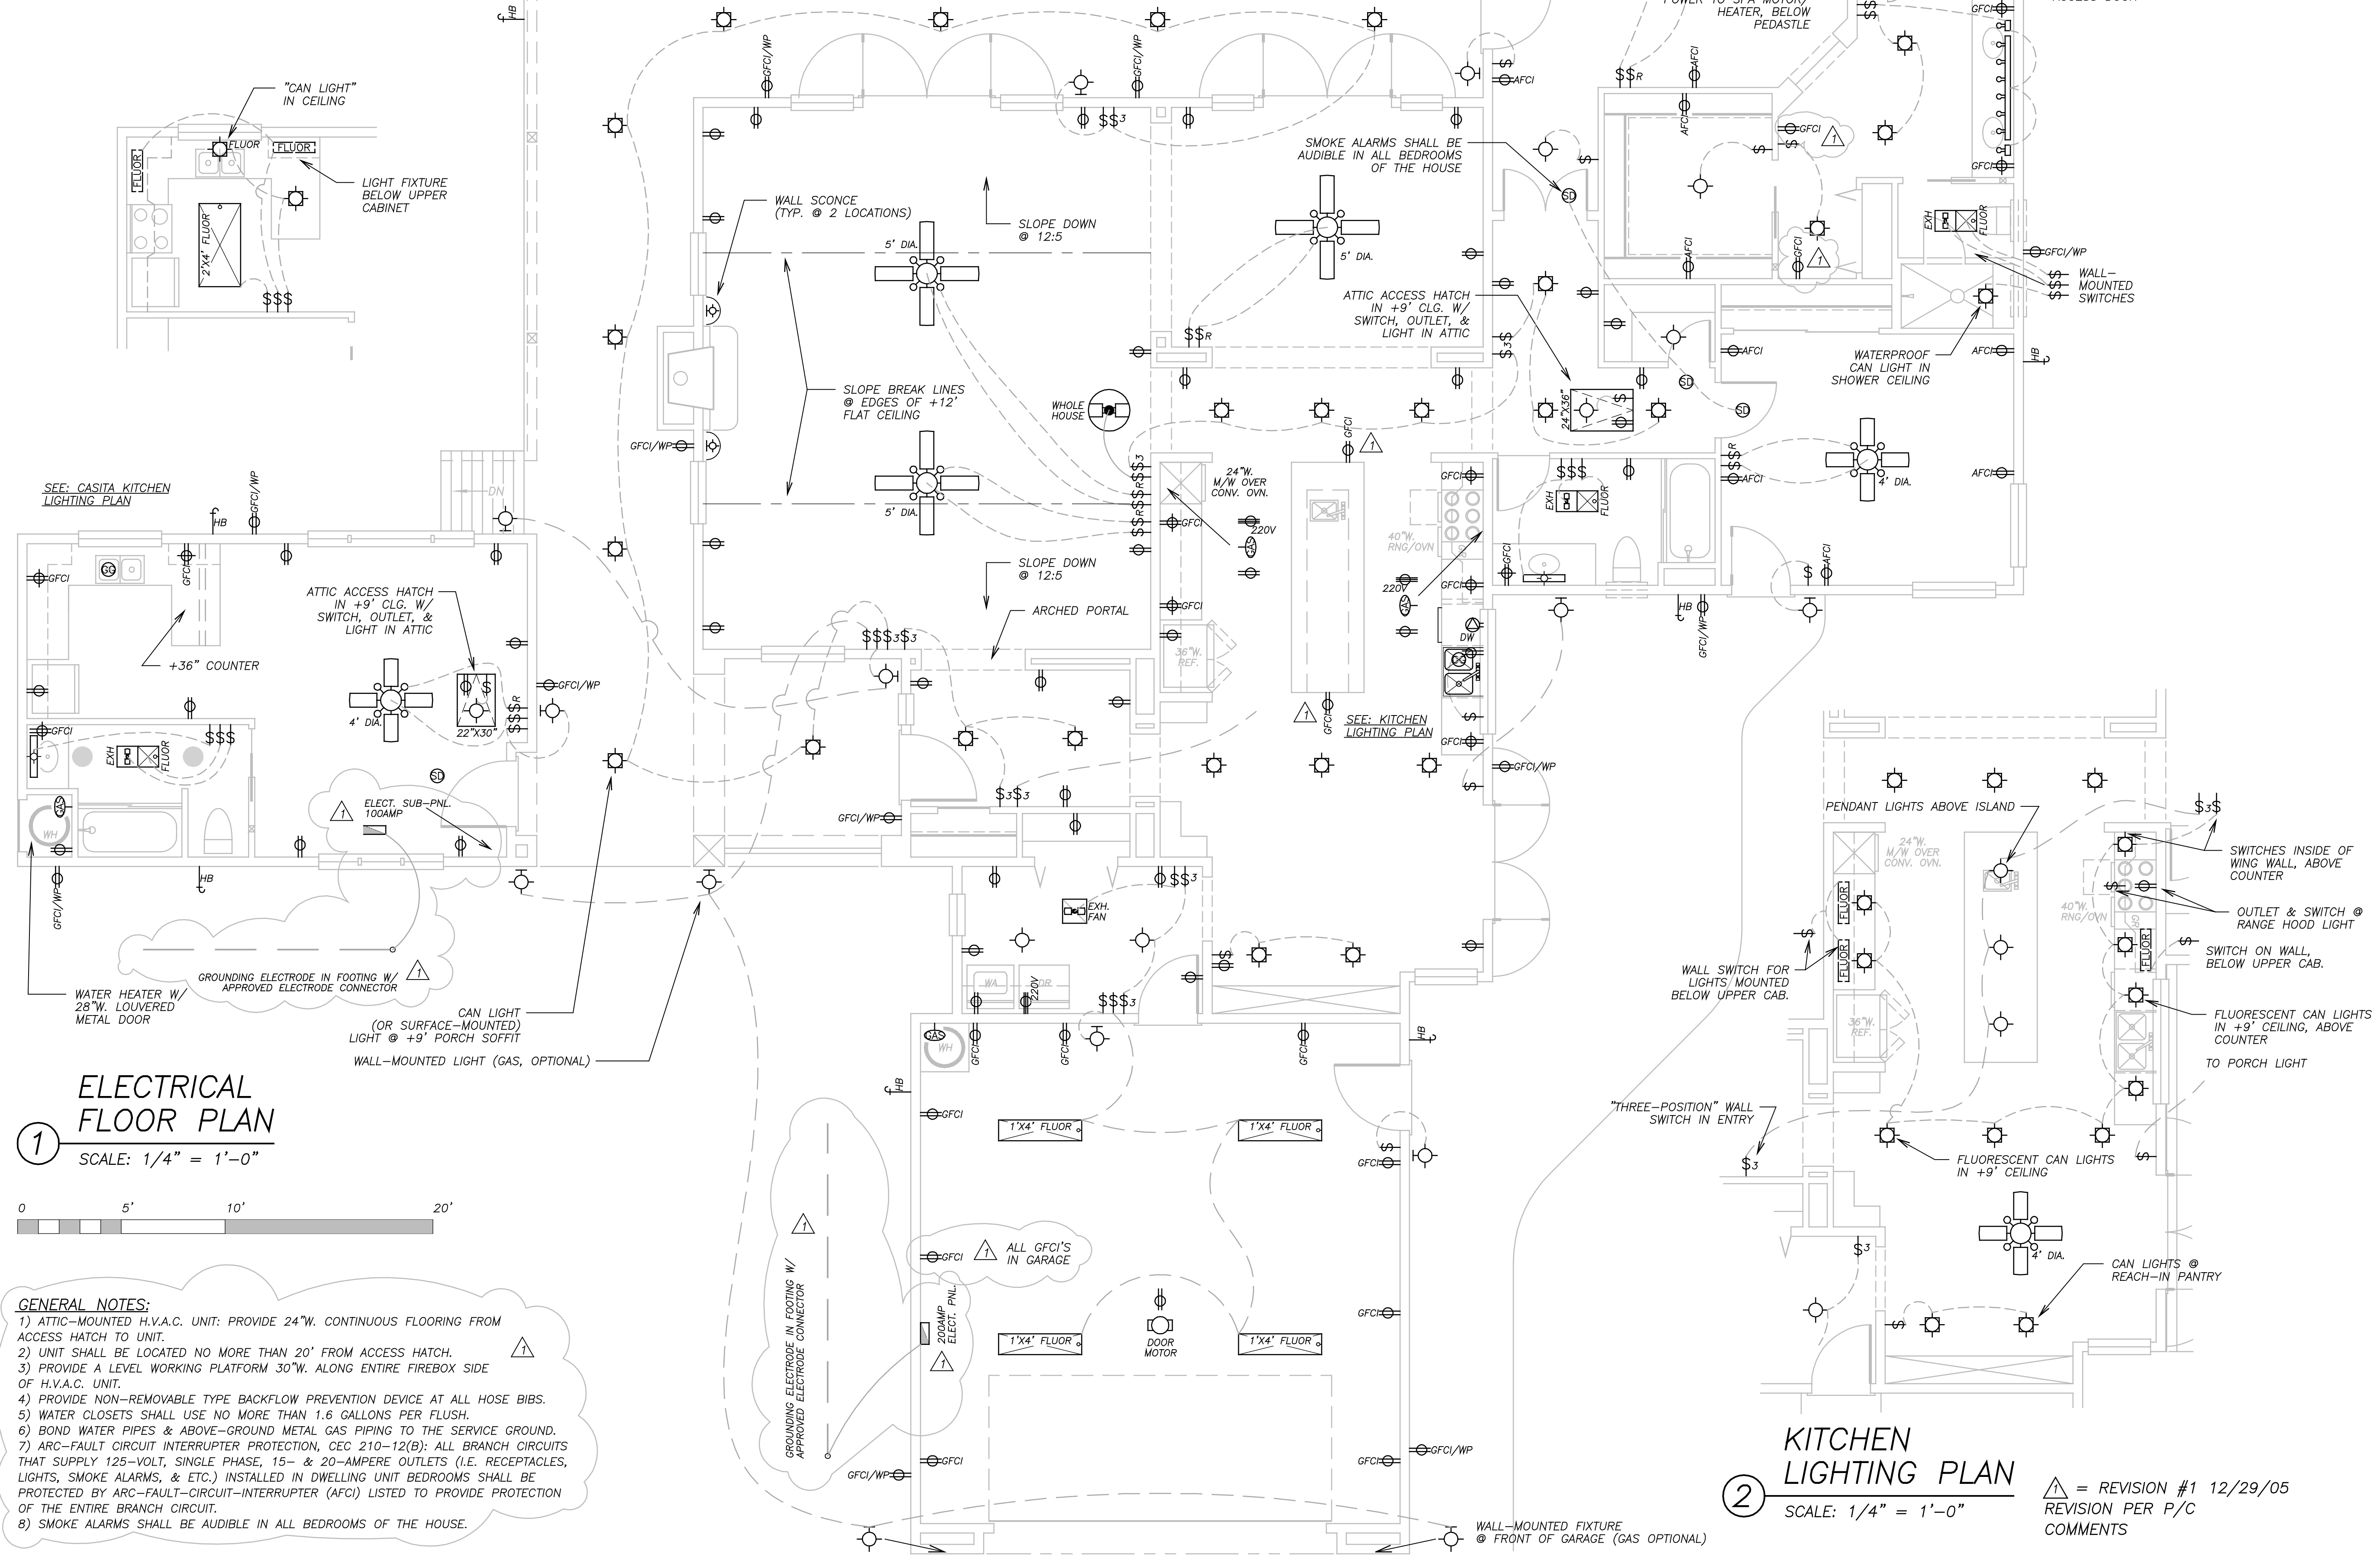

1 ELECTRICAL FLOOR PLAN
SCALE: 1/4" = 1'-0"

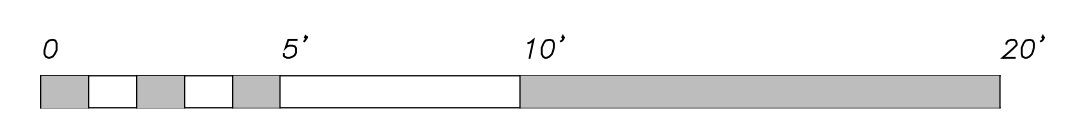

- GENERAL NOTES:**
- 1) ATTIC-MOUNTED H.V.A.C. UNIT: PROVIDE 24"W. CONTINUOUS FLOORING FROM ACCESS HATCH TO UNIT.
 - 2) UNIT SHALL BE LOCATED NO MORE THAN 20' FROM ACCESS HATCH.
 - 3) PROVIDE A LEVEL WORKING PLATFORM 30"W. ALONG ENTIRE FIREBOX SIDE OF H.V.A.C. UNIT.
 - 4) PROVIDE NON-REMOVABLE TYPE BACKFLOW PREVENTION DEVICE AT ALL HOSE BIBS.
 - 5) WATER CLOSETS SHALL USE NO MORE THAN 1.6 GALLONS PER FLUSH.
 - 6) BOND WATER PIPES & ABOVE-GROUND METAL GAS PIPING TO THE SERVICE GROUND.
 - 7) ARC-FAULT CIRCUIT INTERRUPTER PROTECTION, NEC 210-12(B): ALL BRANCH CIRCUITS THAT SUPPLY 125-VOLT, SINGLE PHASE, 15- & 20-AMPERE OUTLETS (I.E. RECEPTACLES, LIGHTS, SMOKE ALARMS, & ETC.) INSTALLED IN DWELLING UNIT BEDROOMS SHALL BE PROTECTED BY ARC-FAULT-CIRCUIT-INTERRUPTER (AFCI) LISTED TO PROVIDE PROTECTION OF THE ENTIRE BRANCH CIRCUIT.
 - 8) SMOKE ALARMS SHALL BE AUDIBLE IN ALL BEDROOMS OF THE HOUSE.

2 KITCHEN LIGHTING PLAN
SCALE: 1/4" = 1'-0"

△ = REVISION #1 12/29/05
REVISION PER P/C COMMENTS