
 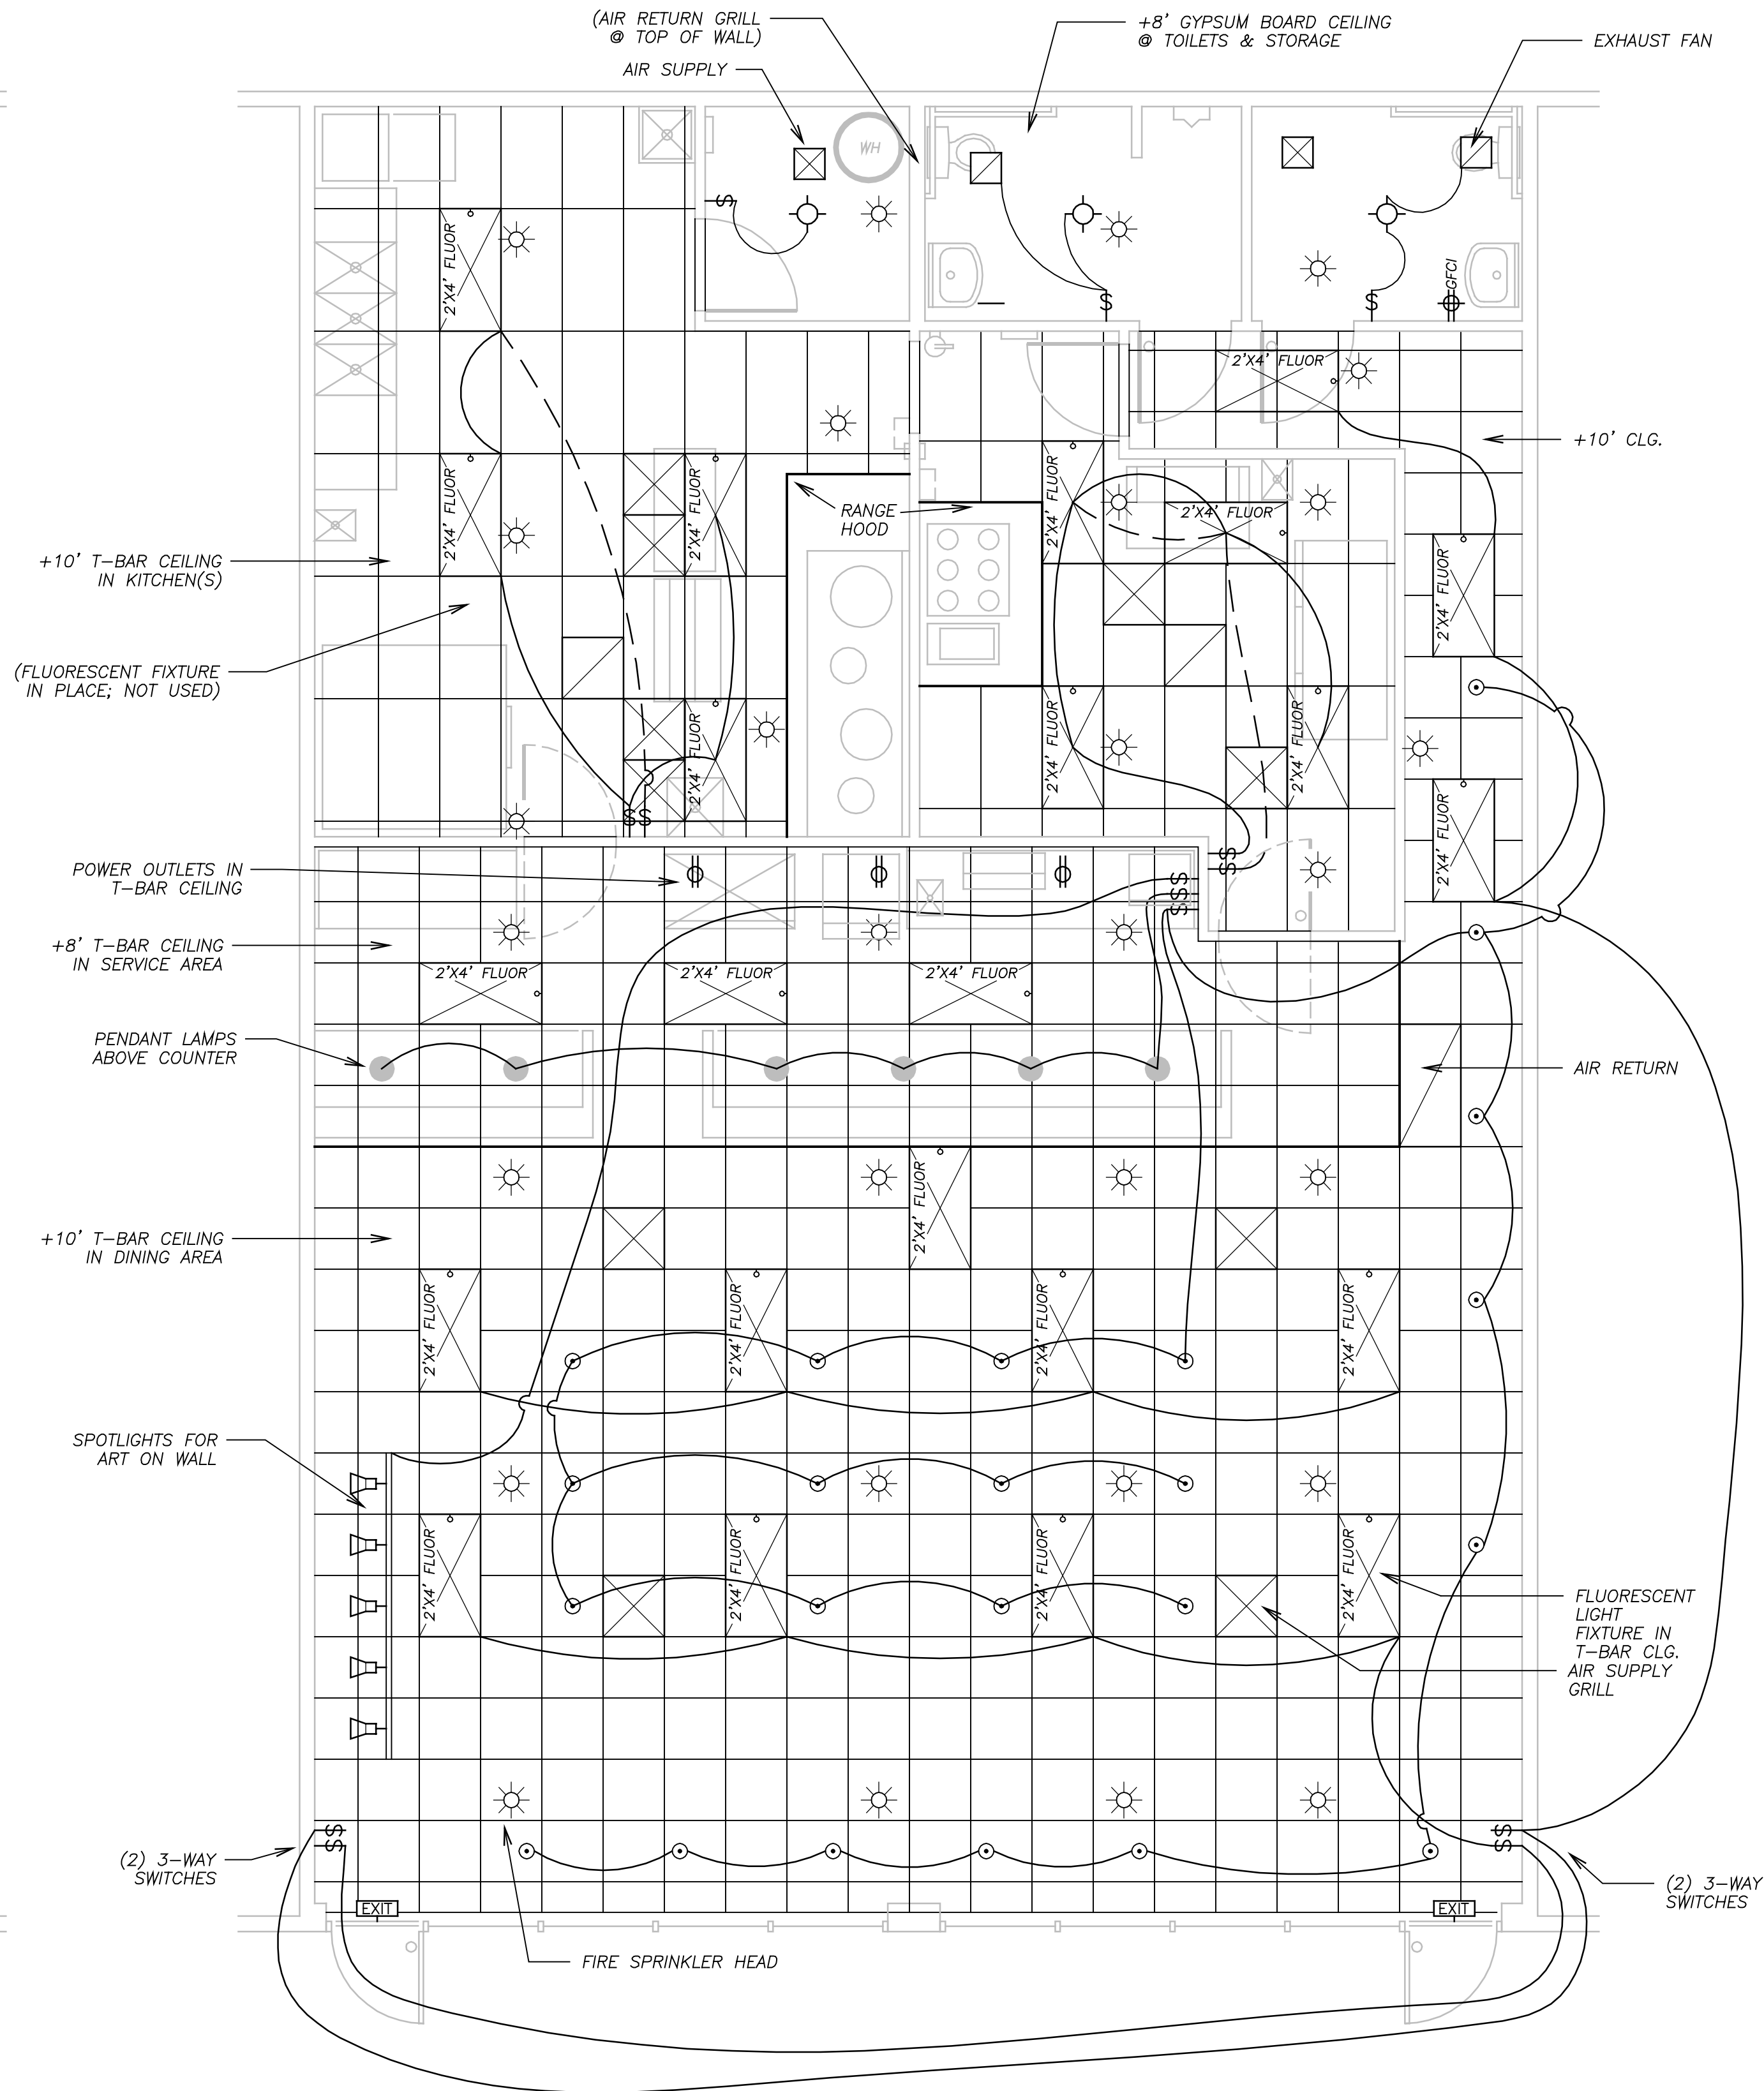



NOTE: ALL FEATURES ARE EXISTING; NO CHANGES.

(EXISTING &) REMODEL ELECTRICAL PLAN

1 SCALE: 1/4" = 1'-0"

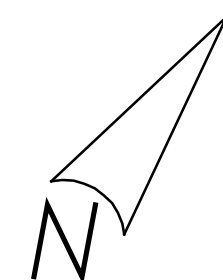

NOTE: H.V.A.C. UNIT MOUNTED ON ROOF

(EXISTING &) REMODEL LIGHTING PLAN

2 SCALE: 1/4" = 1'-0"

ELECTRICAL LEGEND

- STANDARD SINGLE-POLE SWITCH
- RHEOSTAT/DIMMER SWITCH
- THREE-POSITION SWITCH
- FOUR-POSITION SWITCH
- WATERPROOF (OUTDOOR) SWITCH
- STD. 110V DUPLEX OUTLET
- QUAD 110V OUTLET
- "HALF-HOT" (SWITCHED) OUTLET
- ABOVE-COUNTER 110V DUPLEX OUTLET
- "GROUND FAULT INTERRUPTER"
- 220V OUTLET (RANGE/OVEN/WELDING)
- WATERPROOF (EXTERIOR) 110V DUPLEX
- FLOOR-MOUNTED OUTLET
- GAS COCK (RANGE/OVEN/DRIER/WTR. HTR.)
- DISHWASHER OUTLET
- INCANDESCENT SURFACE-MT. CLG. FIXTURE
- RECESSED INCANDESCENT ("CAN-LIGHT")
- FLUORESCENT SURFACE MOUNT
- RECESSED FLUORESCENT
- MOUNTS BELOW KITCHEN UPPER CABINET
- FLUORESCENT BATHROOM FIXTURE
- WALL SCONCE
- EXTERIOR LIGHT
- EXTERIOR LIGHT (SPOT)
- SMOKE DETECTOR (CLG.-MTD.)
- GARBAGE GRINDER (SINK-MTD.; 110V)
- "HOSE BIB"
- THERMOSTAT
- PUSH-BUTTON (DOORBELL)
- OCCUPANCY SENSOR
- MOTION SENSOR