


ELECTRICAL PLAN for TENNANT IMPROVEMENT

1

SCALE: 1/4" = 1'-0"

SEE ALSO: PLUMBING PLAN

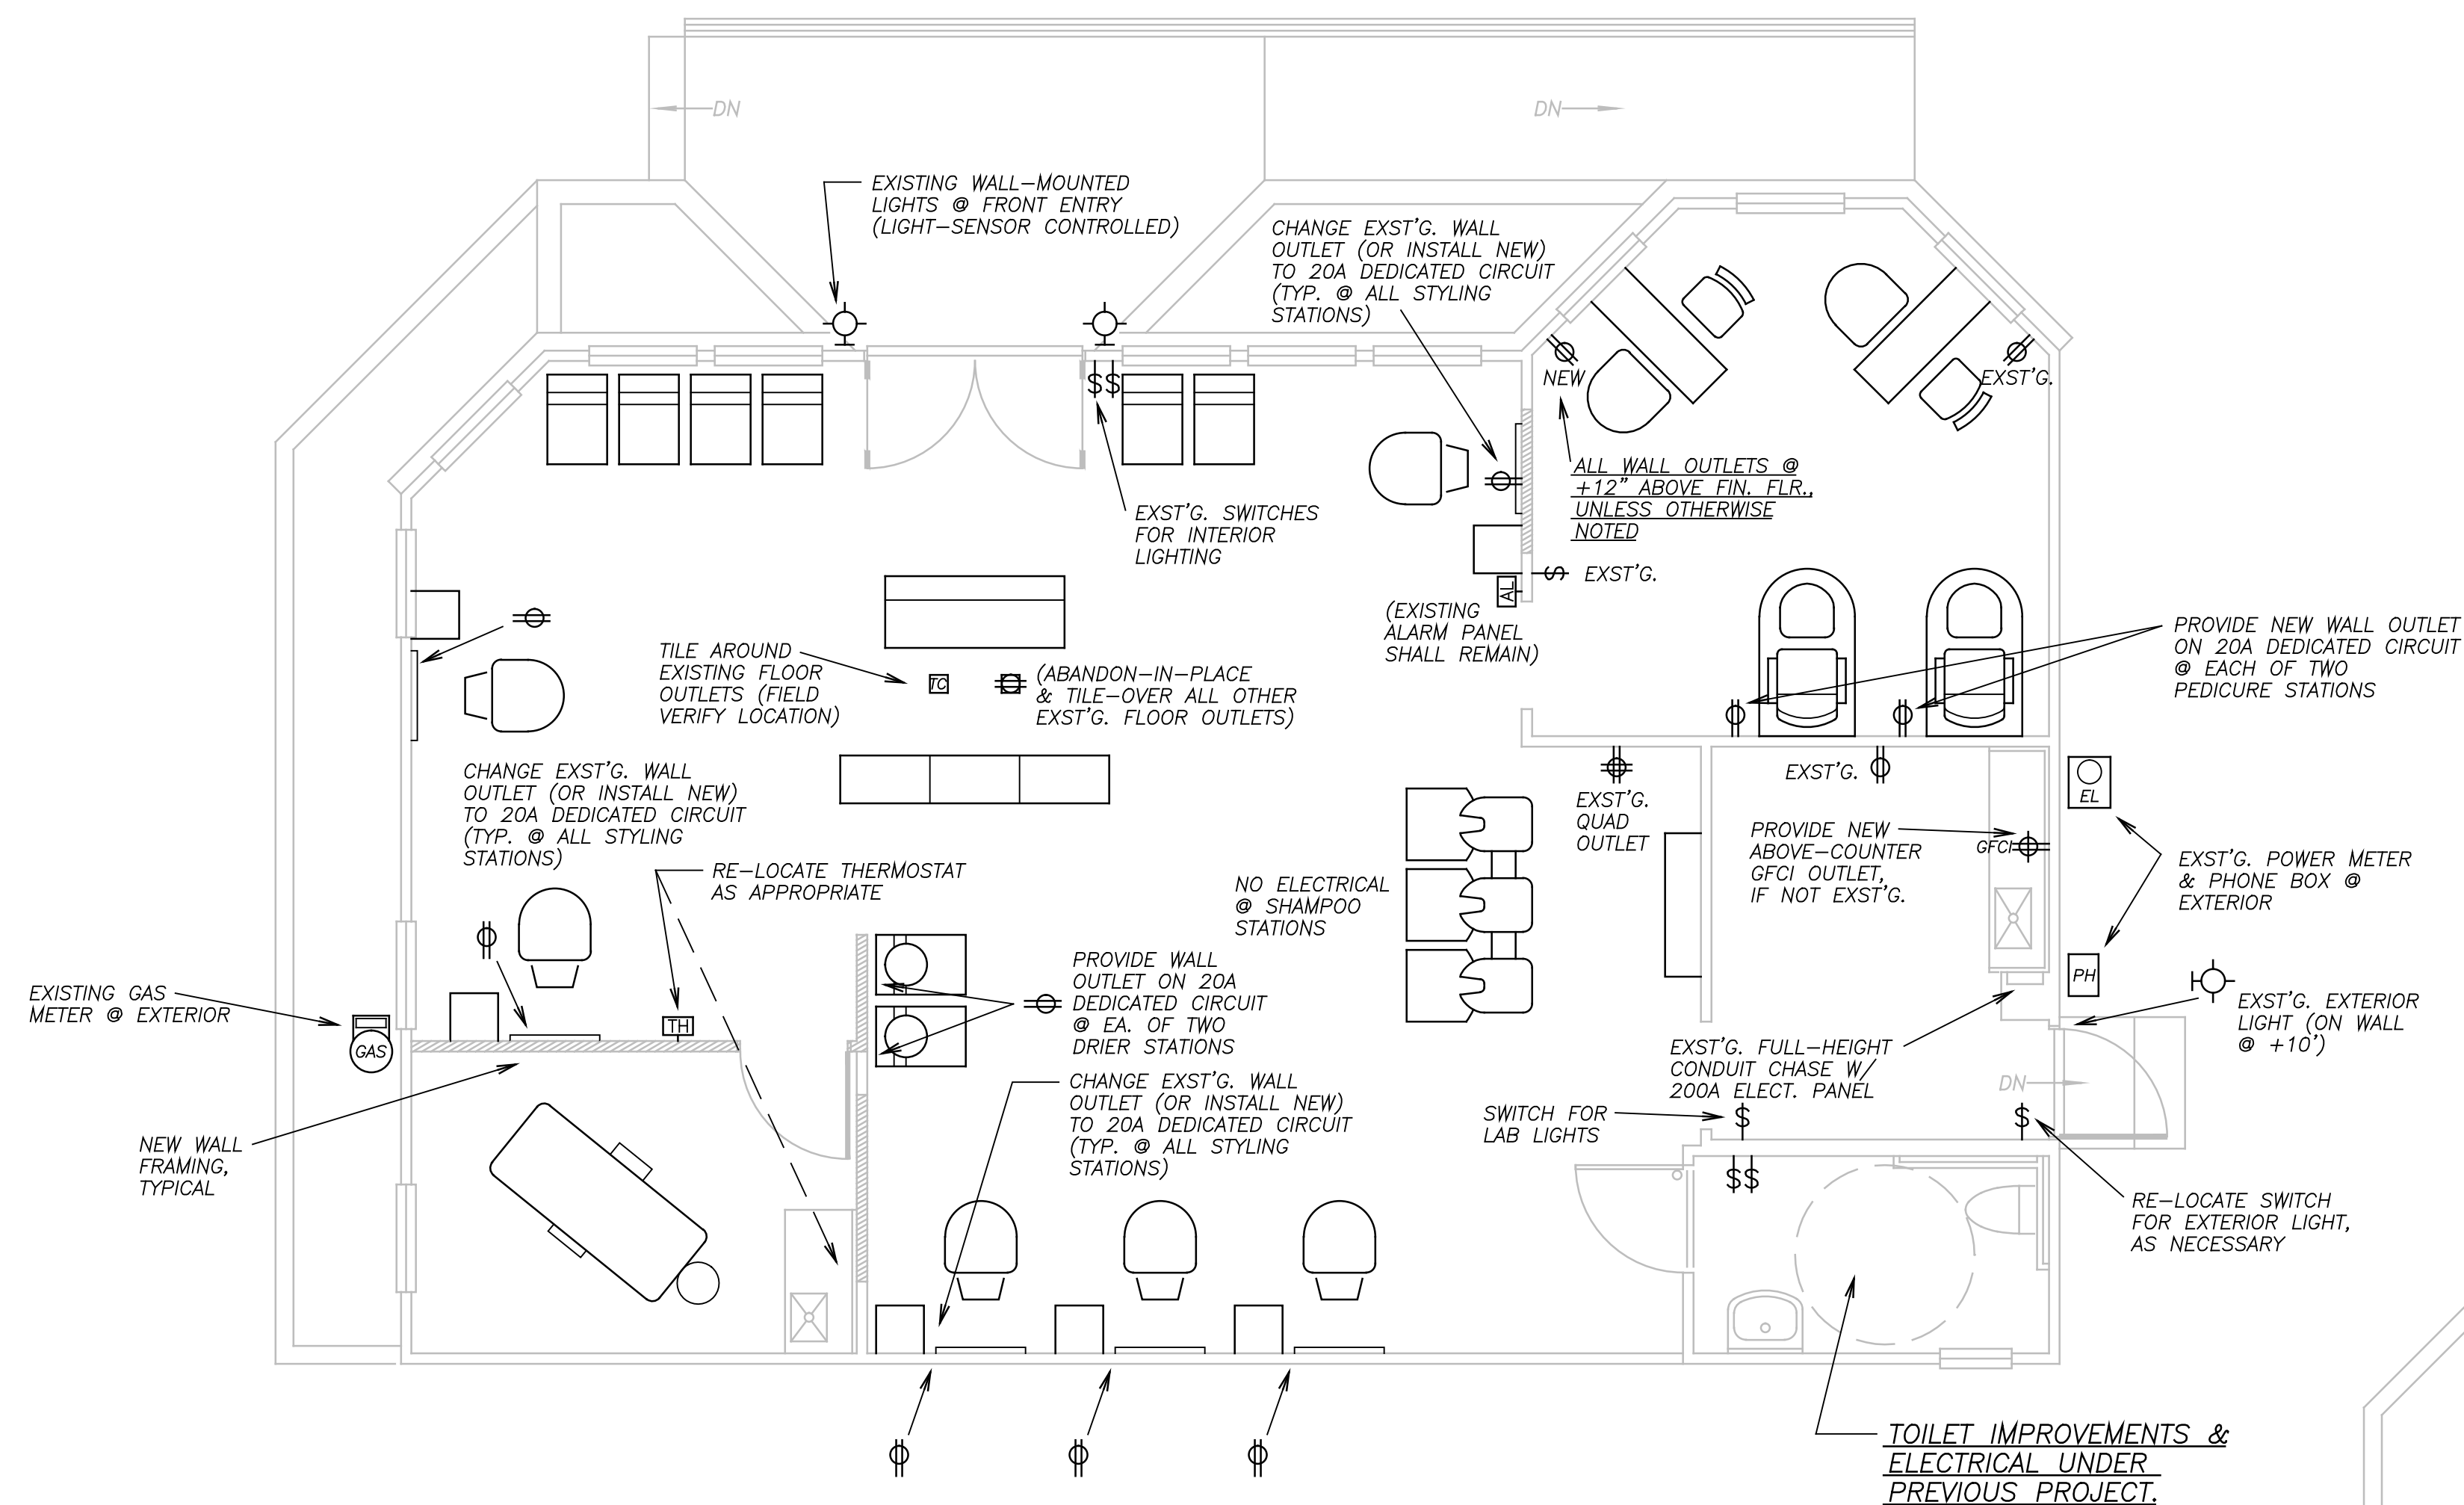

ELECTRICAL LEGEND

- \$ STANDARD SINGLE-POLE SWITCH
- \$R \$D RHEOSTAT/DIMMER SWITCH
- \$3 THREE-POSITION SWITCH
- \$4 FOUR-POSITION SWITCH
- \$W WATERPROOF (OUTDOOR) SWITCH
- \$D STD. 110V DUPLEX OUTLET
- \$4 STD. 110V OUTLET
- \$H "HALF-HOT" (SWITCHED) OUTLET


- FLUOR ABOVE-COUNTER 110V DUPLEX OUTLET
- "GROUND FAULT INTERRUPTER"
- 220V OUTLET (RANGE/OVEN/WELDING)
- WATERPROOF (EXTERIOR) 110V DUPLEX
- FLOOR-MOUNTED OUTLET
- GAS COCK (RANGE/OVEN/DRIER/WTR. HTR.)
- DISHWASHER OUTLET
- INCANDESCENT SURFACE-MT. CLG. FIXTURE
- RECESSED INCANDESCENT ("CAN-LIGHT")
- FLUOR FLOURESCENT SURFACE MOUNT

- FLUOR RECESSED FLUORESCENT
- FLUOR MOUNTS BELOW KITCHEN UPPER CABINET
- FLUOR FLUORESCENT BATHROOM FIXTURE
- WALL SCONCE
- EXTERIOR LIGHT
- EXTERIOR LIGHT (SPOT)
- SMOKE DETECTOR (CLG.-MTD.)
- GARBAGE GRINDER (SINK-MTD.; 110V)
- "HOSE BIB"
- THERMOSTAT
- PUSH-BUTTON (DOORBELL)
- OCCUPANCY SENSOR
- MOTION SENSOR

PLUMBING PLAN for TENNANT IMPROVEMENT

2

SCALE: 1/4" = 1'-0"

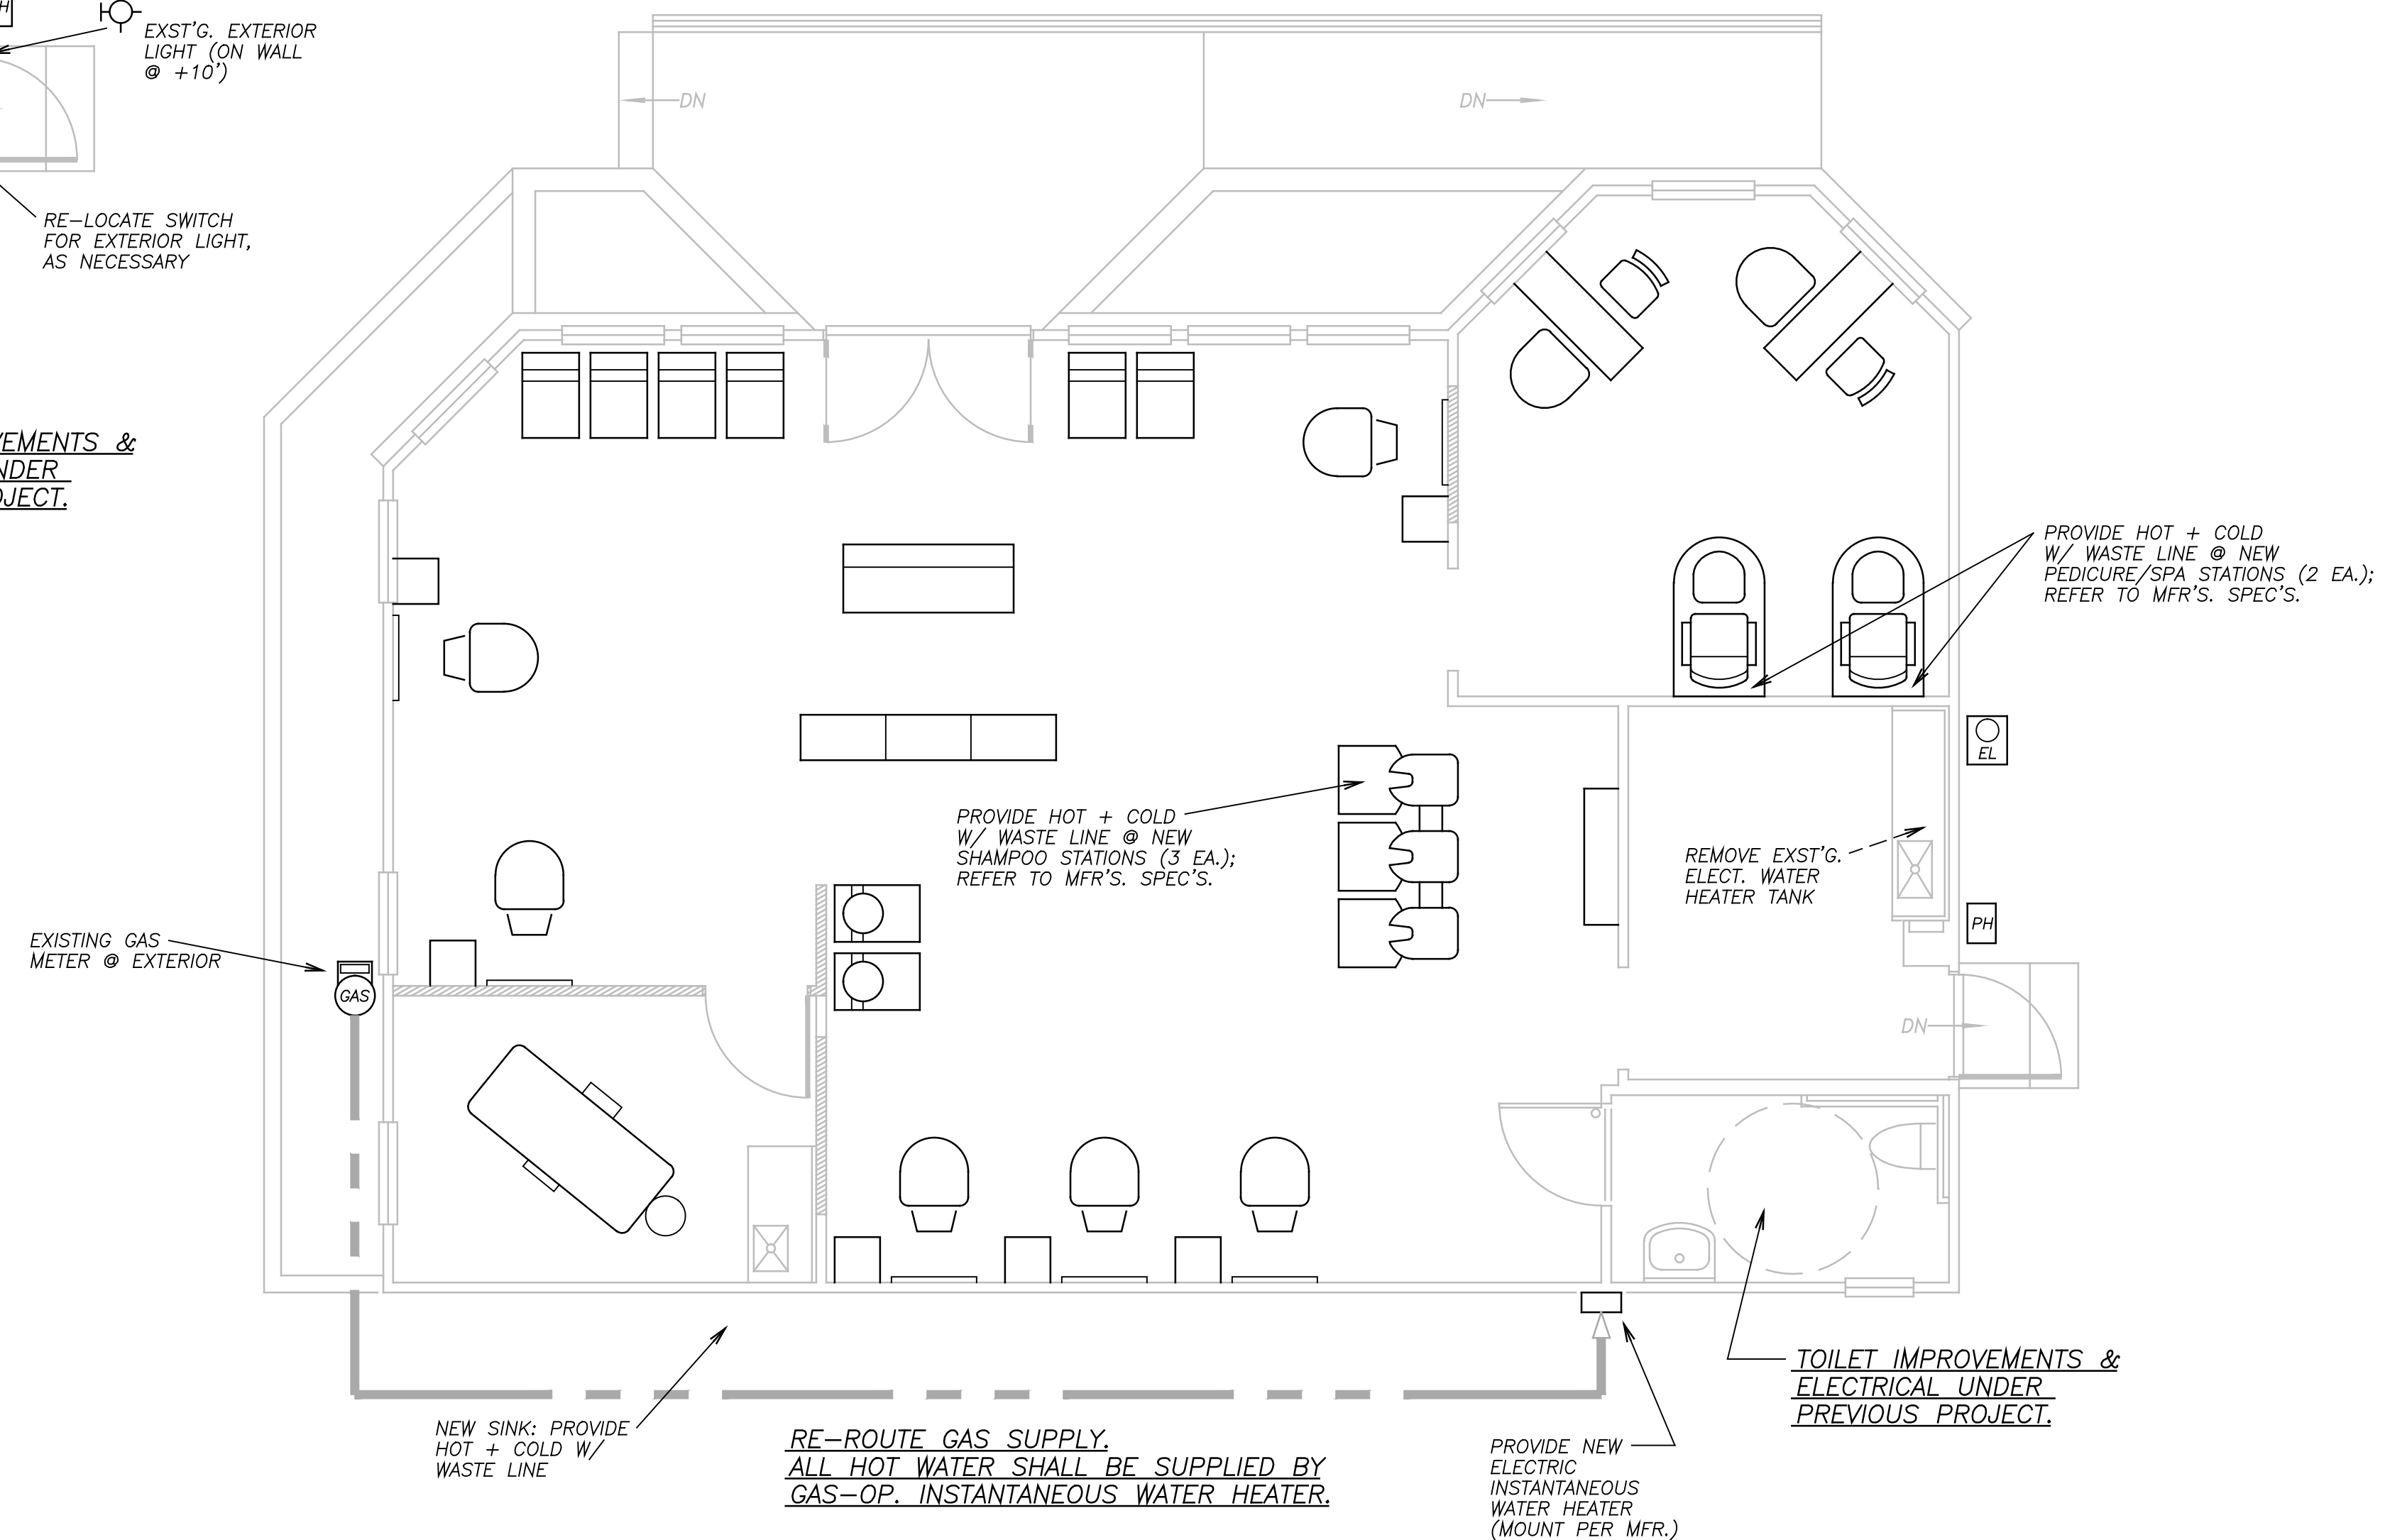

drawn by: BRUCE W. O'BRIEN
phone: (916) 962-3128
co. lic. #: 329325

TENNANT IMPROVEMENTS
10351 FAIR OAKS BLVD., FAIR OAKS, CA 95628

REVISION DATE:
2/23/10
FILE NUMBER:
10-06

SHEET NUMBER:
EP-1
OF: 2