


WATER HEATER SCHEDULE						
MF'R.	MODEL #	VOLTAGE	AMPERAGE	WEIGHT	SUPPLY	QUANTITY
DHC	DHC 6-2	208/230V	30A	4.6 LBS.	1/2" DIA. NPT	2 EA.

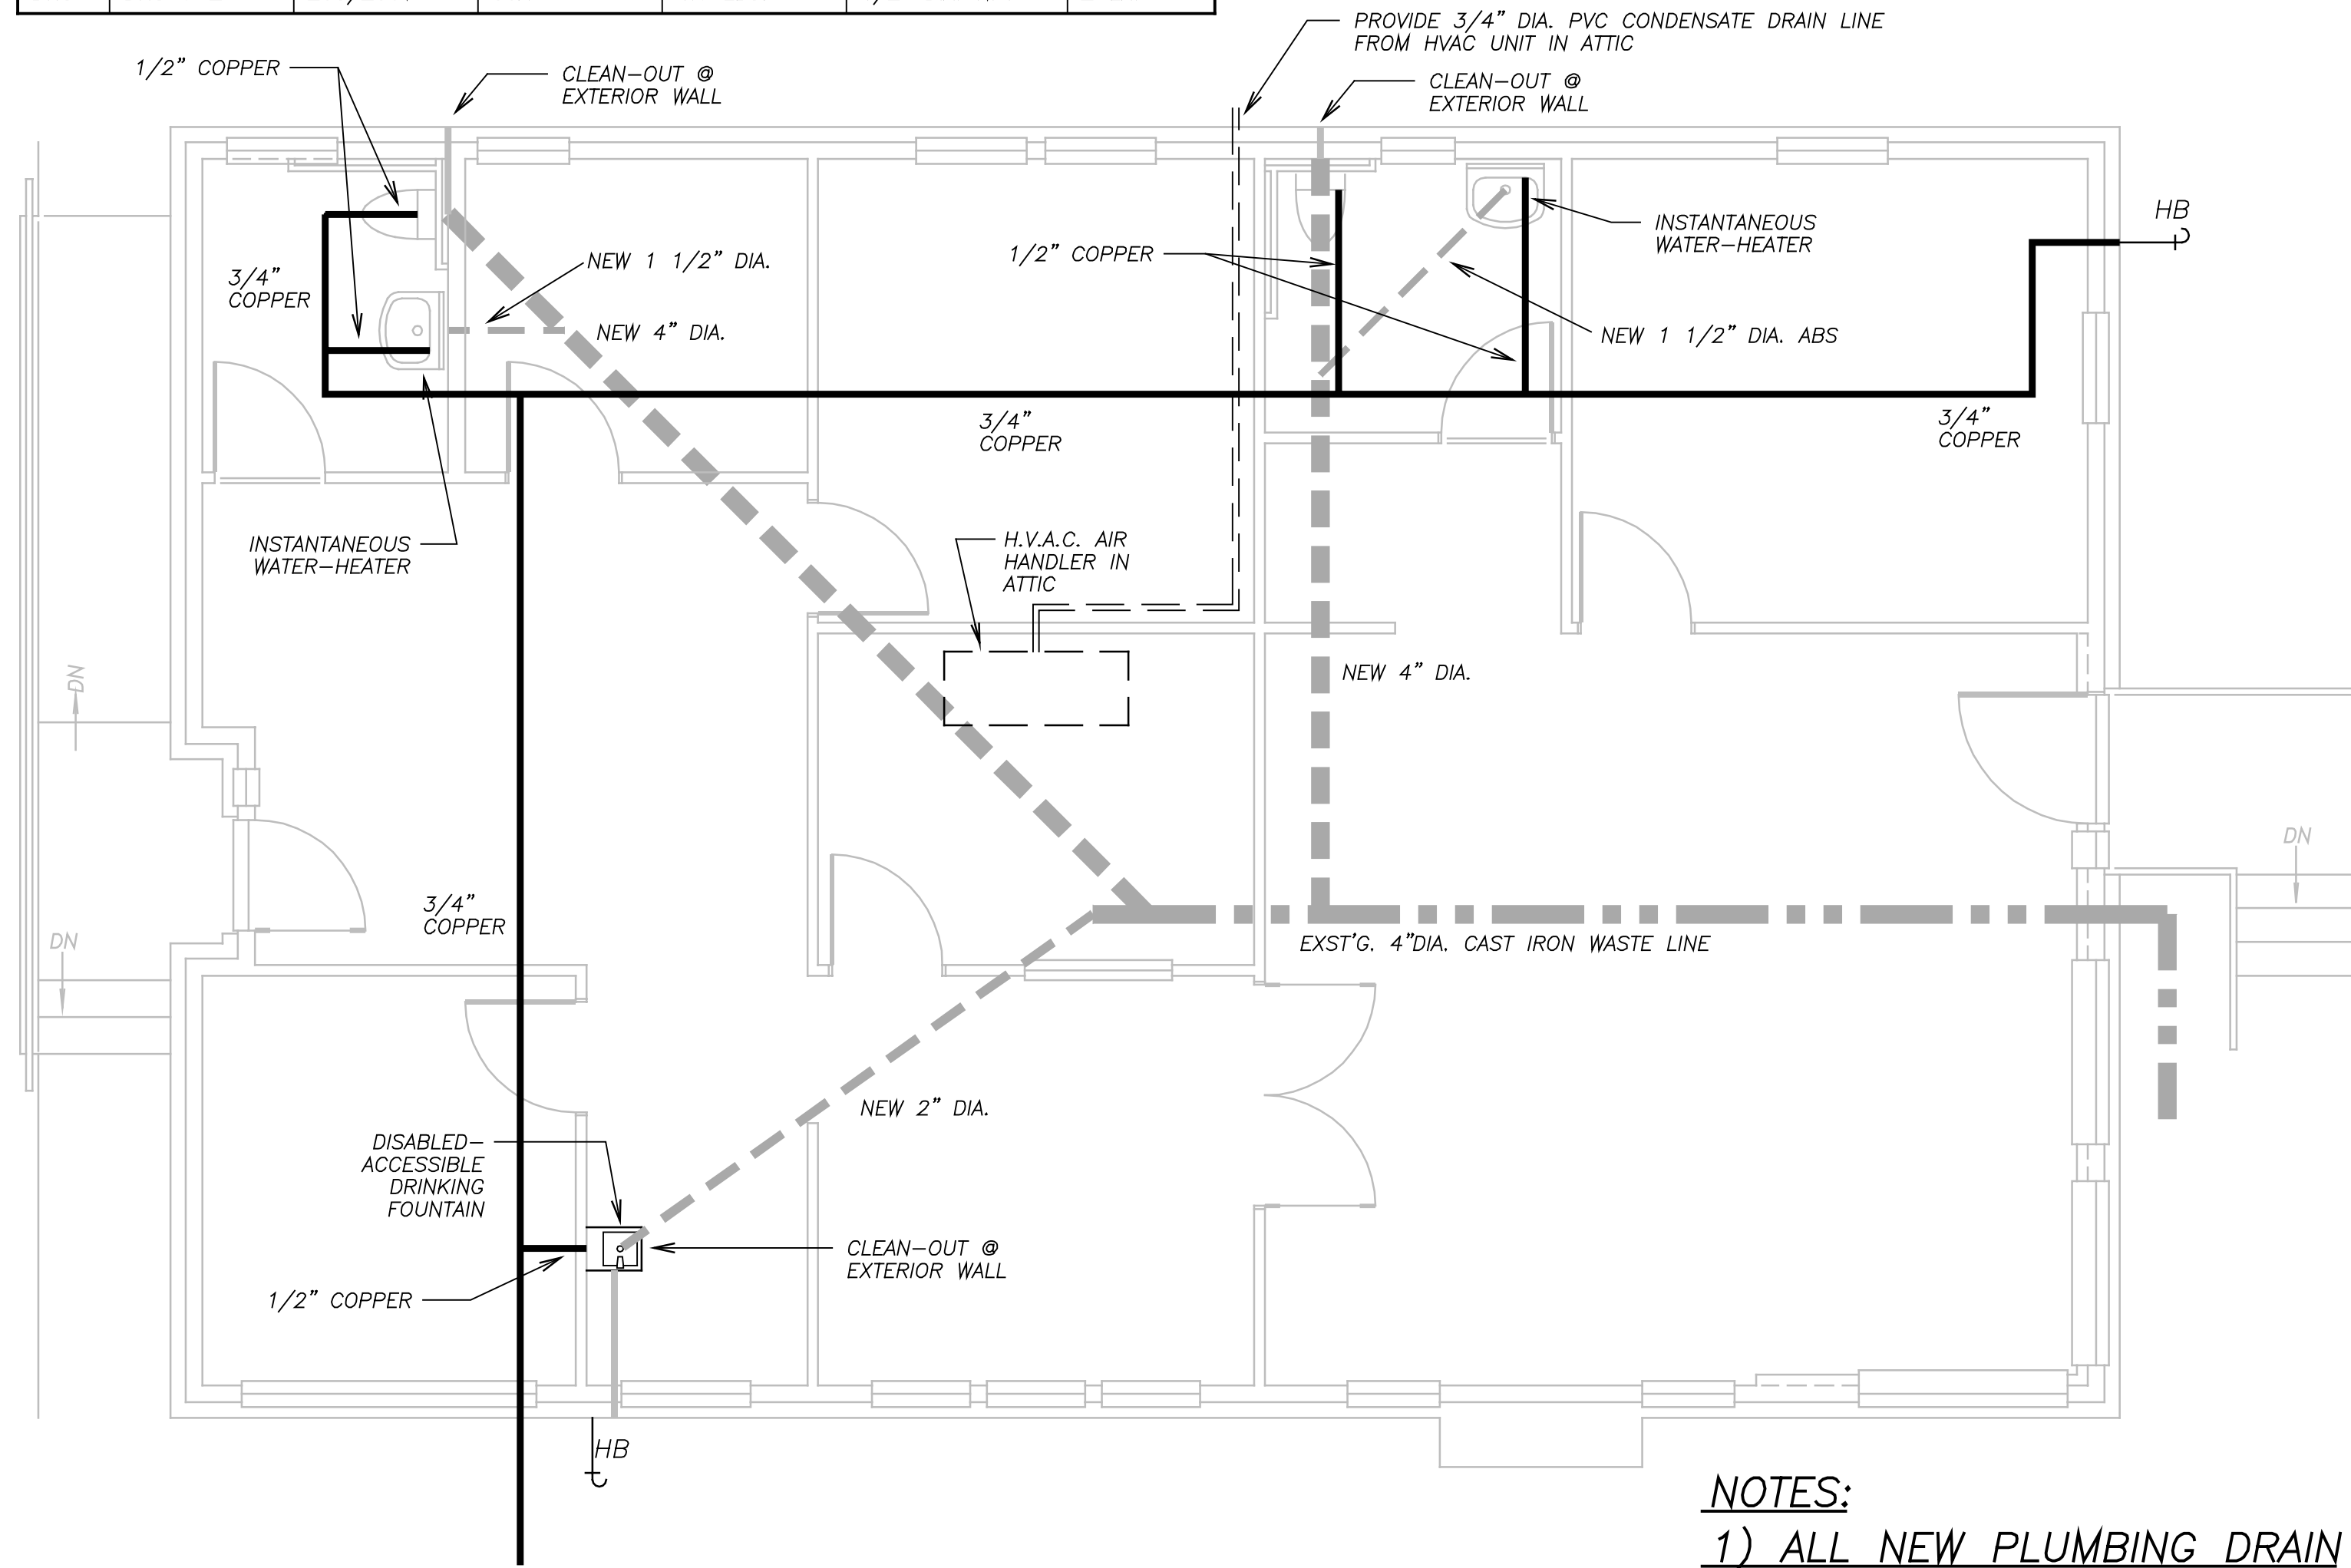

① PLUMBING SCHEMATIC FLOOR PLAN
SCALE: 1/4" = 1'-0"

- NOTES:
- 1) ALL NEW PLUMBING DRAIN LINES INSTALLED SHALL BE A.B.S.
 - 2) VENTS SHALL BE RUN @ ROOF ABOVE WALL LOCATIONS.

drawn by: BRUCE W. O'BRIEN
phone: (916) 962-3128
co. lic. #: -

TENNANT IMPRVMT. for 'INALLIANCE'
658 & 660 MAIN ST., PLACERVILLE, CA

REVISION DATE:
11/4/08
FILE NUMBER:
07-11

SHEET NUMBER:
P-1
OF: -